



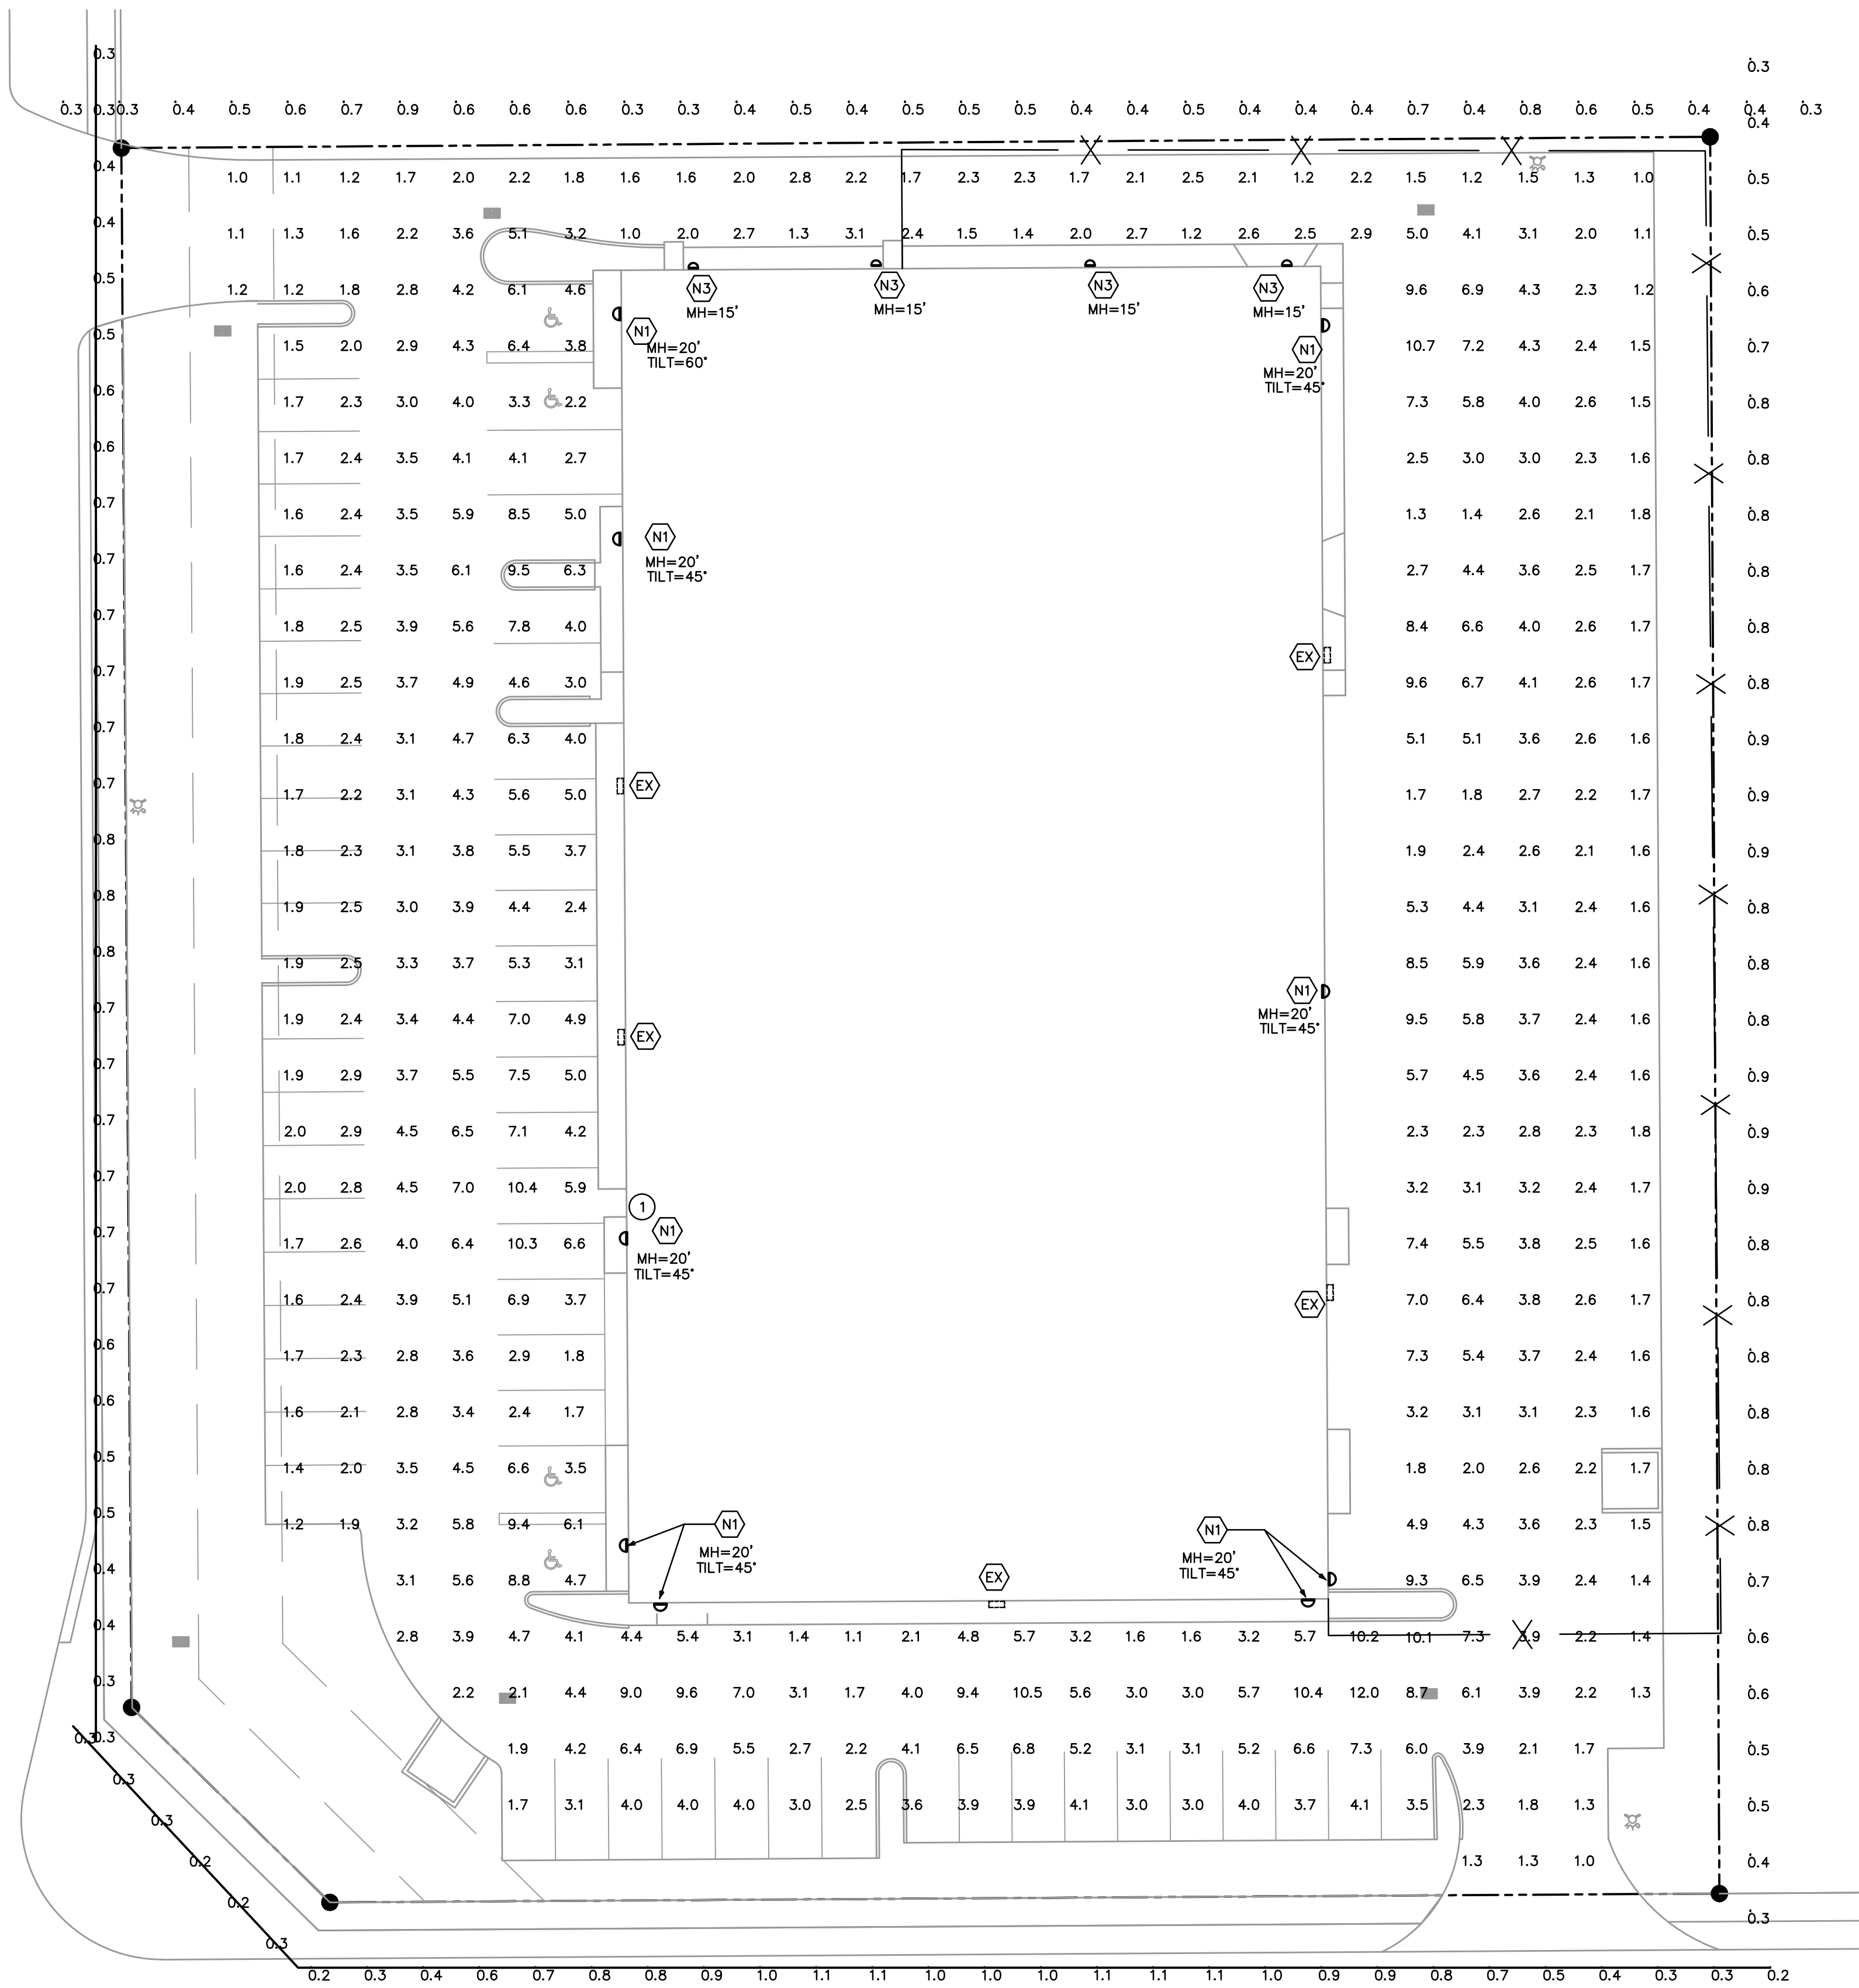

SITE
PHOTOMETRIC PLAN
1"=20'-0" NORTH

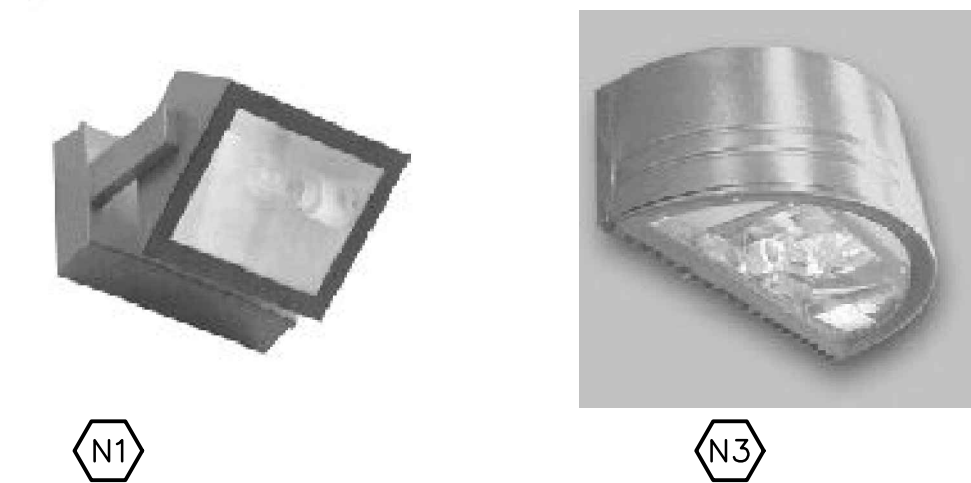

Luminaire Schedule							
Symbol	Label	[MANUFAC]	Description	Arrangement	Total Lamp Lumens	LLF	Lum. Watts
	EX		EXISTING WALLPACK				
	N3		VISIONAIRE LIGHTING, MHC-1 T3-100PS DL	SINGLE	9000	0.720	115
	N1		VISIONAIRE LIGHTING, APK-1 ASYM LIGHT DIST 400M-WM	SINGLE	36000	0.720	452

Calculation Summary							
Label	Calc Type	Units	Avg	Max	Min	Avg/Min	Max/Min
east	Illuminance	Fc	0.71	0.9	0.3	2.37	3.00
north	Illuminance	Fc	0.48	0.9	0.3	1.60	3.00
south	Illuminance	Fc	0.66	1.1	0.2	3.30	5.50
west	Illuminance	Fc	0.58	0.8	0.3	1.93	2.67
parking	Illuminance	Fc	3.68	12.0	1.0	3.68	12.00

date

revision

KAMM Consulting
1407 West Newport Center Drive
West Palm Beach, Florida 33411
Phone 561.949.2200 Fax 561.949.2201
engineering@kammconsulting.com
www.kammconsulting.com
Certification of Professional Engineer
3-31-14
date
signed

1700 BARNES ROAD
MARGATE, FLORIDA 33063

project title:

sheet title:

proj. no.: 2014-0223

project manager: RAK

checked by: LTC/RAK

scale: AS NOTED

date: 03/26/14

sheet

project