
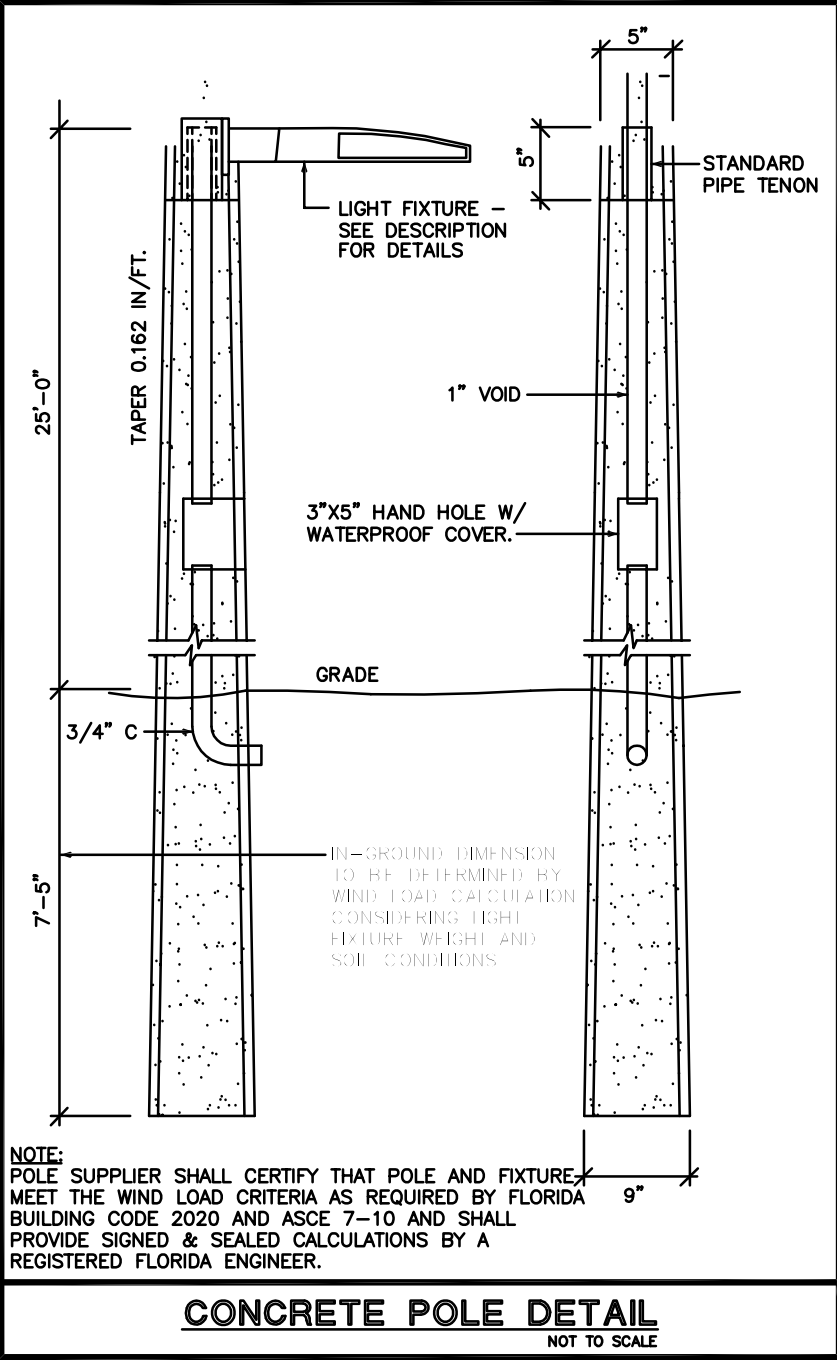


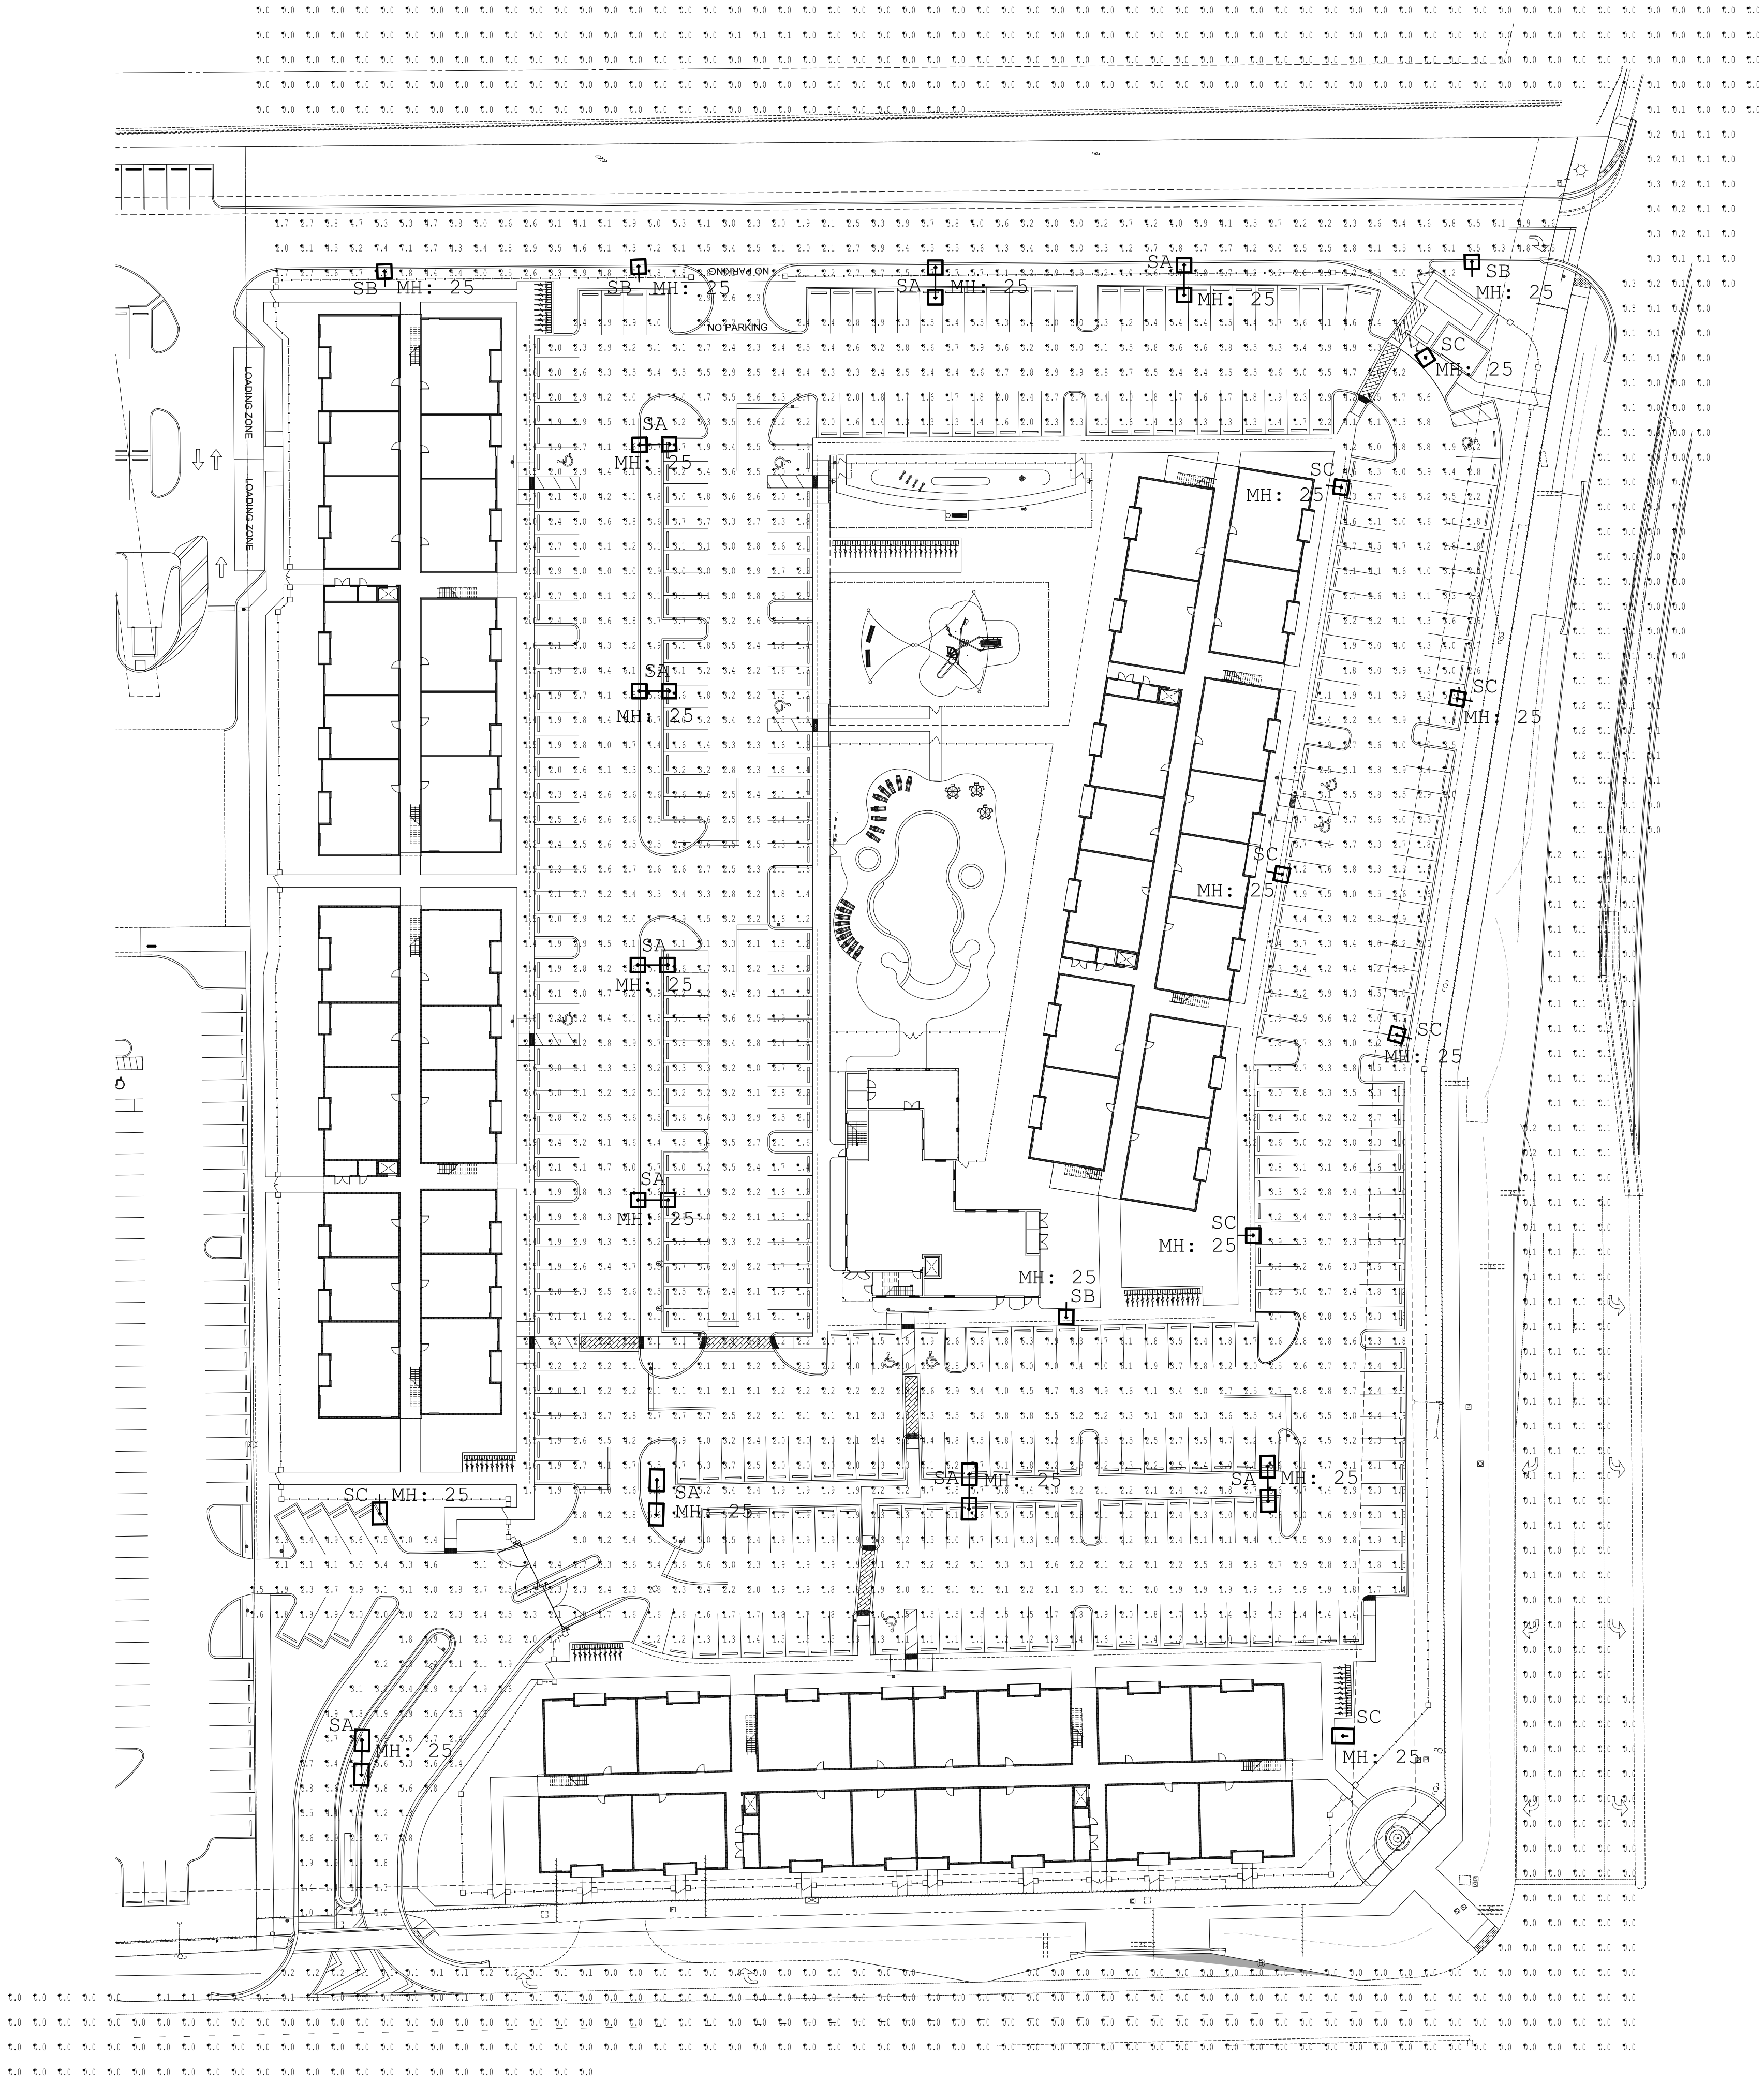

Calculation Summary							
Label	CalcType	Units	Avg	Max	Min	Avg/Min	Max/Min
Parking and Roadway	Illuminance	Fc	3.13	8.3	1.0	3.13	8.30
Spill	Illuminance	Fc	0.03	0.4	0.0	N.A.	N.A.

Luminaire Schedule						
Symbol	Qty	Label	Arrangement	LLF	Description	
SA	10	SA	BACK-BACK	0.900	LSI Lighting MRM-LED-24L-SIL-5W-40-70CRI, 2@180°	
SB	5	SB	SINGLE	0.900	LSI Lighting MRM-LED-24L-SIL-3-40-70CRI, Single Head	
SC	6	SC	SINGLE	0.900	LSI Lighting MRM-LED-30L-SIL-FT-40-70CRI-IL, Single Head	

4577 Nob Hill Road, Suite 102
Sunrise, FL 33351
www.suntecheng.com

Sun-Tech
Engineering, Inc.
Engineers - Planners - Surveyors

STE

Certificate of Auth. #097/LB 7019
Phone (954) 777-3123
Fax (954) 777-3114


REVISIONS		DESCRIPTION
NO.	DATE	

MARGATEFLORIDA

MARQUESA APARTMENTS

SITE PHOTOMETRICS PLAN

DATE:	SEP 2021
SCALE:	1" = 40'
DESIGNED BY:	GSJ
DRAWN BY:	GSJ
JOB #:	21-4105

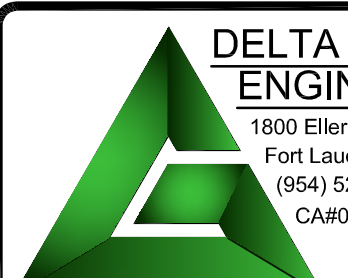**DELTA G CONSULTING**
ENGINEERS, INC.
1800 Eller Drive, Suite 570
Fort Lauderdale, FL 33316
(954) 527-1112
CA#00009181

PJT. MGR: GEORGE SANJUAN
PROJECT #: 211010

GEORGE SANJUAN, P.E.
FLORIDA LICENSE #46100