


LUMINAIRE SCHEDULE						
Symbol	Label	Qty	Catalog Number	File	LLF	Watts
	SA	21	BEACON PRODUCTS VPL 96NB-220 3K T4 UNV COLOR (POLE MT @ 30 FT AFG)	VP-L-96NB-220-3K-T4.ies	0.85	440
	SB	24	BEACON PRODUCTS VPL 96NB-220 3K T4 UNV COLOR (POLE MT @ 30 FT AFG)	VP-L-96NB-220-3K-T4.ies	0.85	220
	SC	6	BEACON PRODUCTS VPL 96NB-220 3K T2 UNV COLOR (POLE MT @ 30 FT AFG)	VP-L-96NB-220-3K-T2.ies	0.85	220

STATISTICS					
Description	Avg	Max	Min	Max/Min	Avg/Min
Parking Lot	4.6 fc	12.7 fc	2.0 fc	6.4:1	2.3:1

NOTE:
THE SPECIFIED LIGHT FIXTURE IS IDA (INTERNATIONALLY DARK SKY COMPLIANT – NO UP LIGHT – SEE SPEC SHEET) (THE 3K OFFERING)

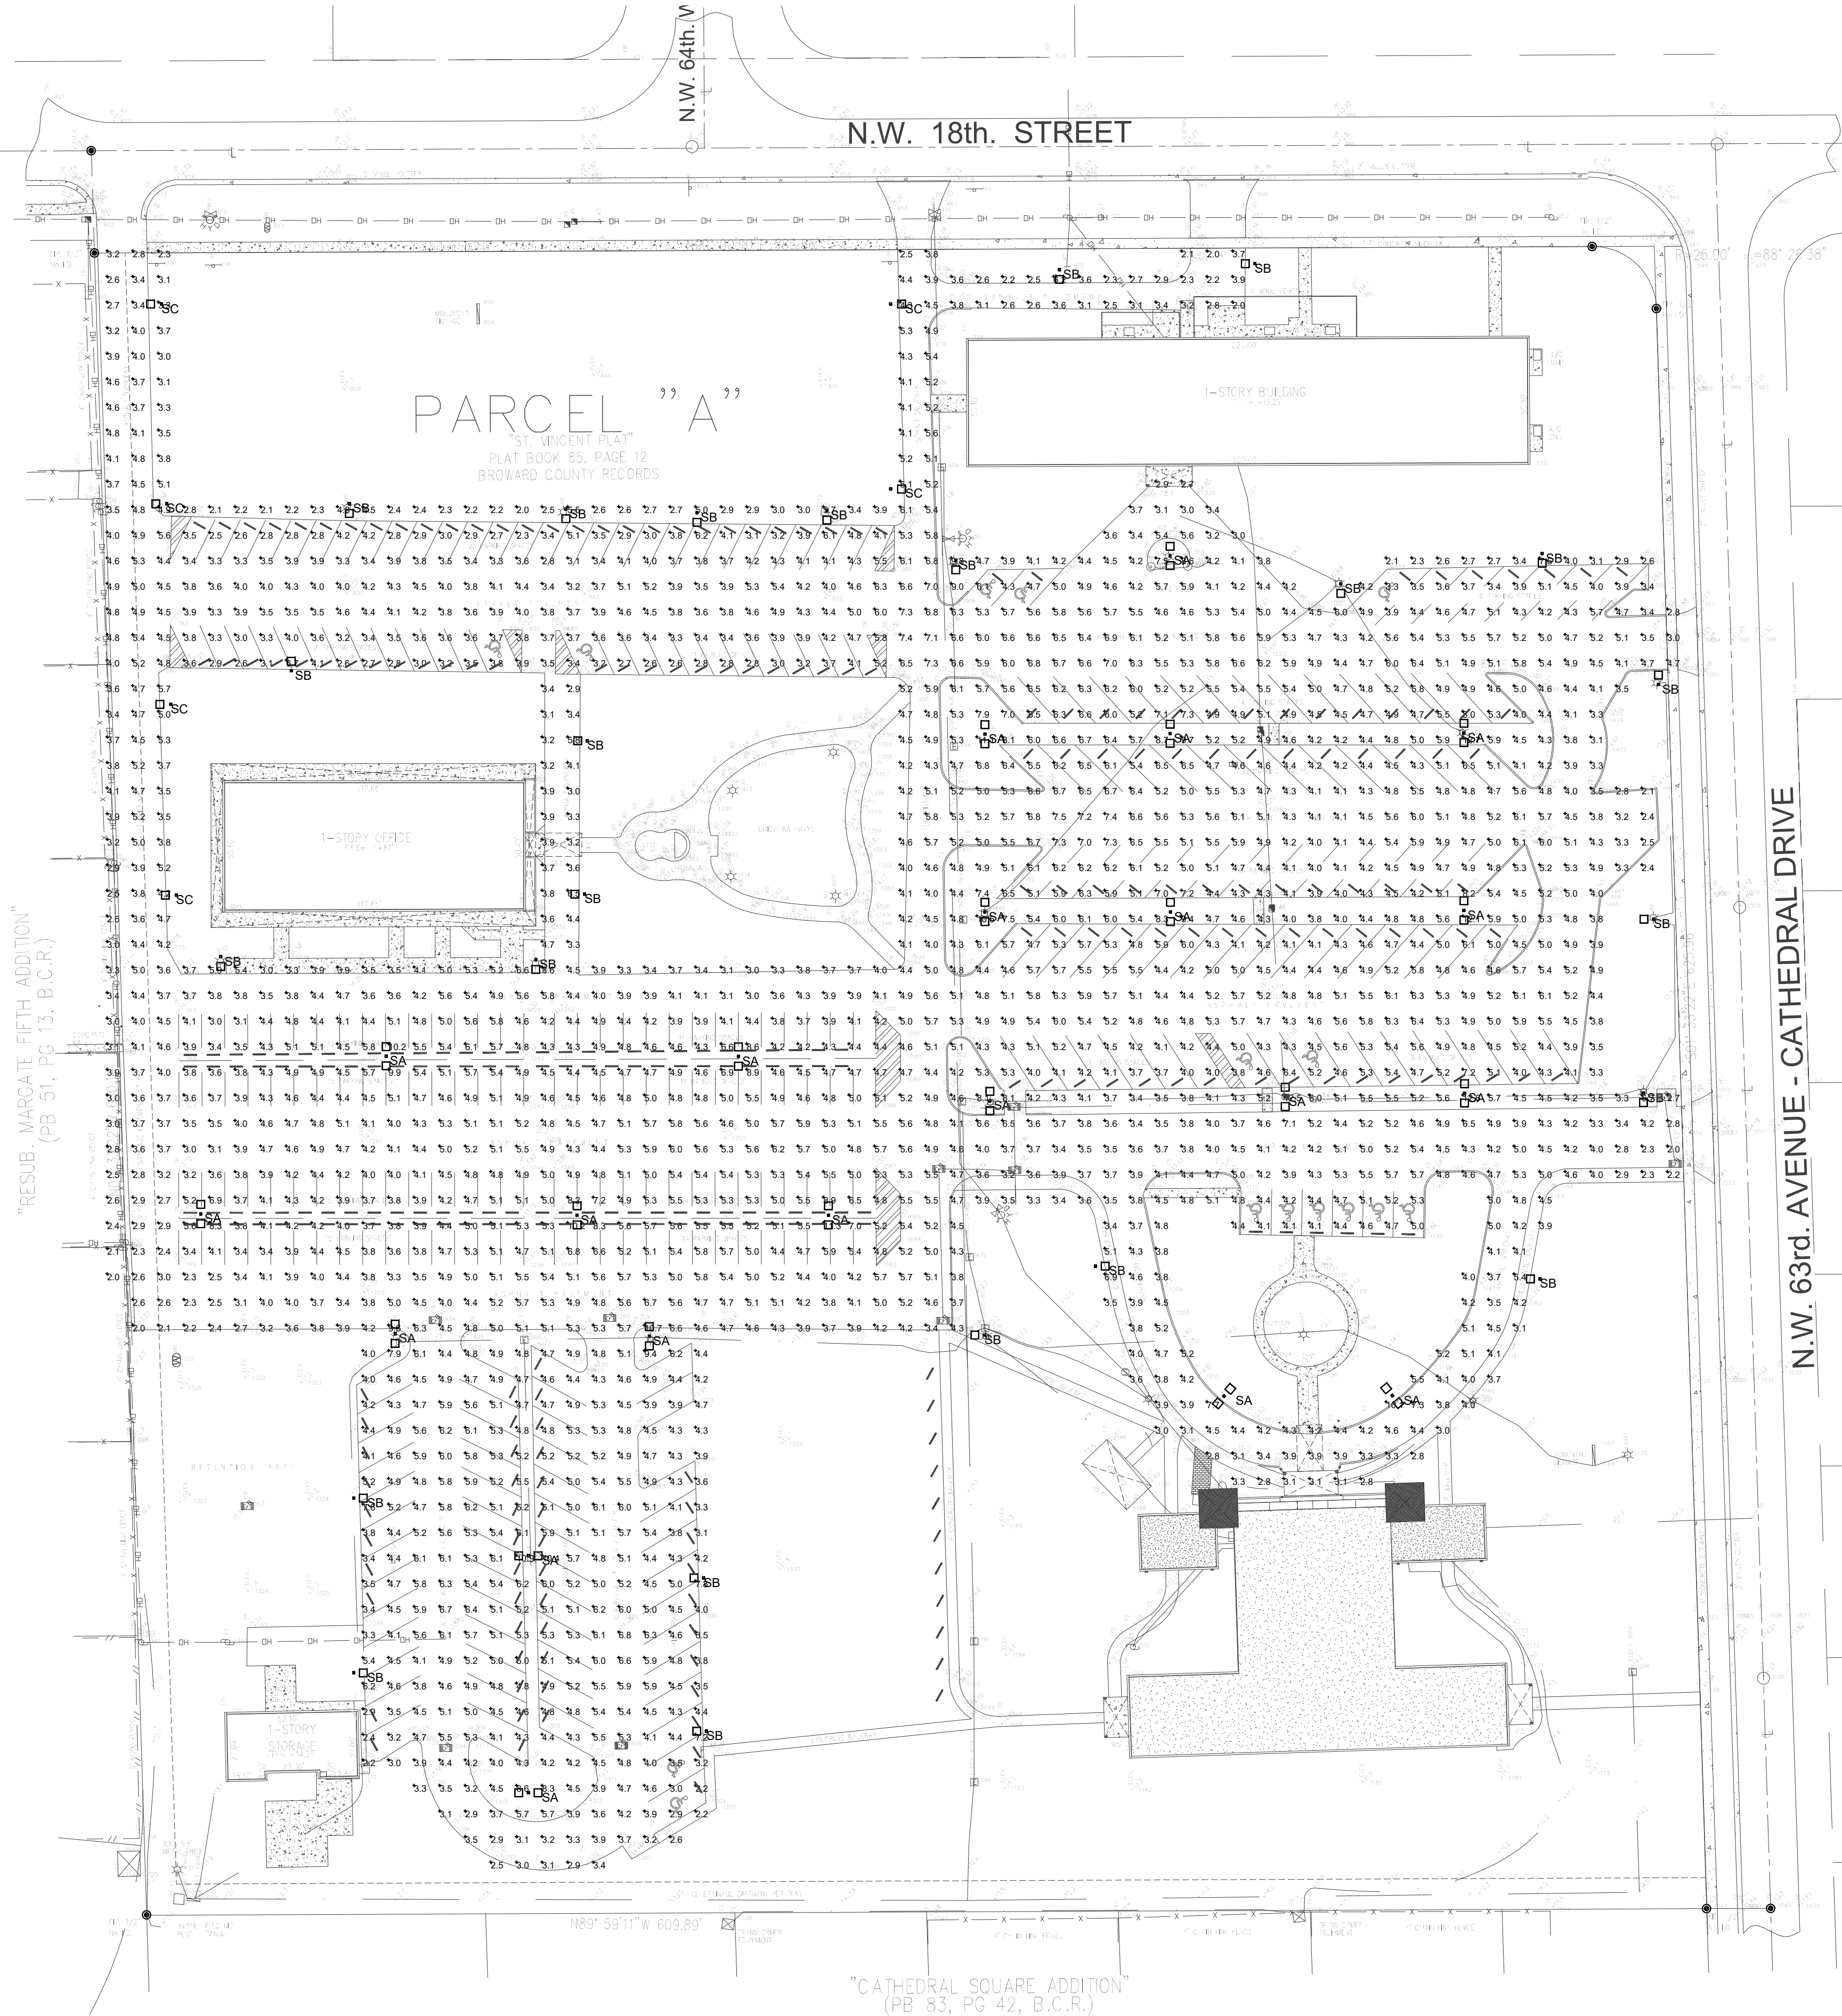

1 PHOTOMETRIC PLAN
SCALE: 1"=40'-0"

PREMIER
CONSULTING ENGINEERS, LLC

MECHANICAL | ELECTRICAL | PLUMBING
ENGINEERING + CONSULTING

CDA # 29969

2799 NW 2ND AVE, SUITE H-202, BOCA RATON, FL 33431
PH: 561.672.7344 | FAX: 561.892.7700
EMAIL: MEP@PREMIER-ENGINEERS.COM

SEAL

KAMAL HALABI, P.E.
FL P.E. # 639970

ST VINCENT CATHOLIC CHURCH
18TH STREET MARGATE FLORIDA

API GROUP, INC.

5921 VISTA LINDA LANE
BOCA RATON - FLORIDA 33443

Phone : (561) 392-1120 Fax : (561) 392-1502



File Location:
Project No
DATE 1-25-17
Phase PERMIT
REVISIONS

Sheet No:

PH-1

1 OF 2

JOHN DALE HEAVY
ARCHITECT AR 0013186
AAC 001900

This document is the property of API GROUP, Inc.
Copyright © 2014. All rights reserved.
Unauthorized use or reproduction is prohibited.

