



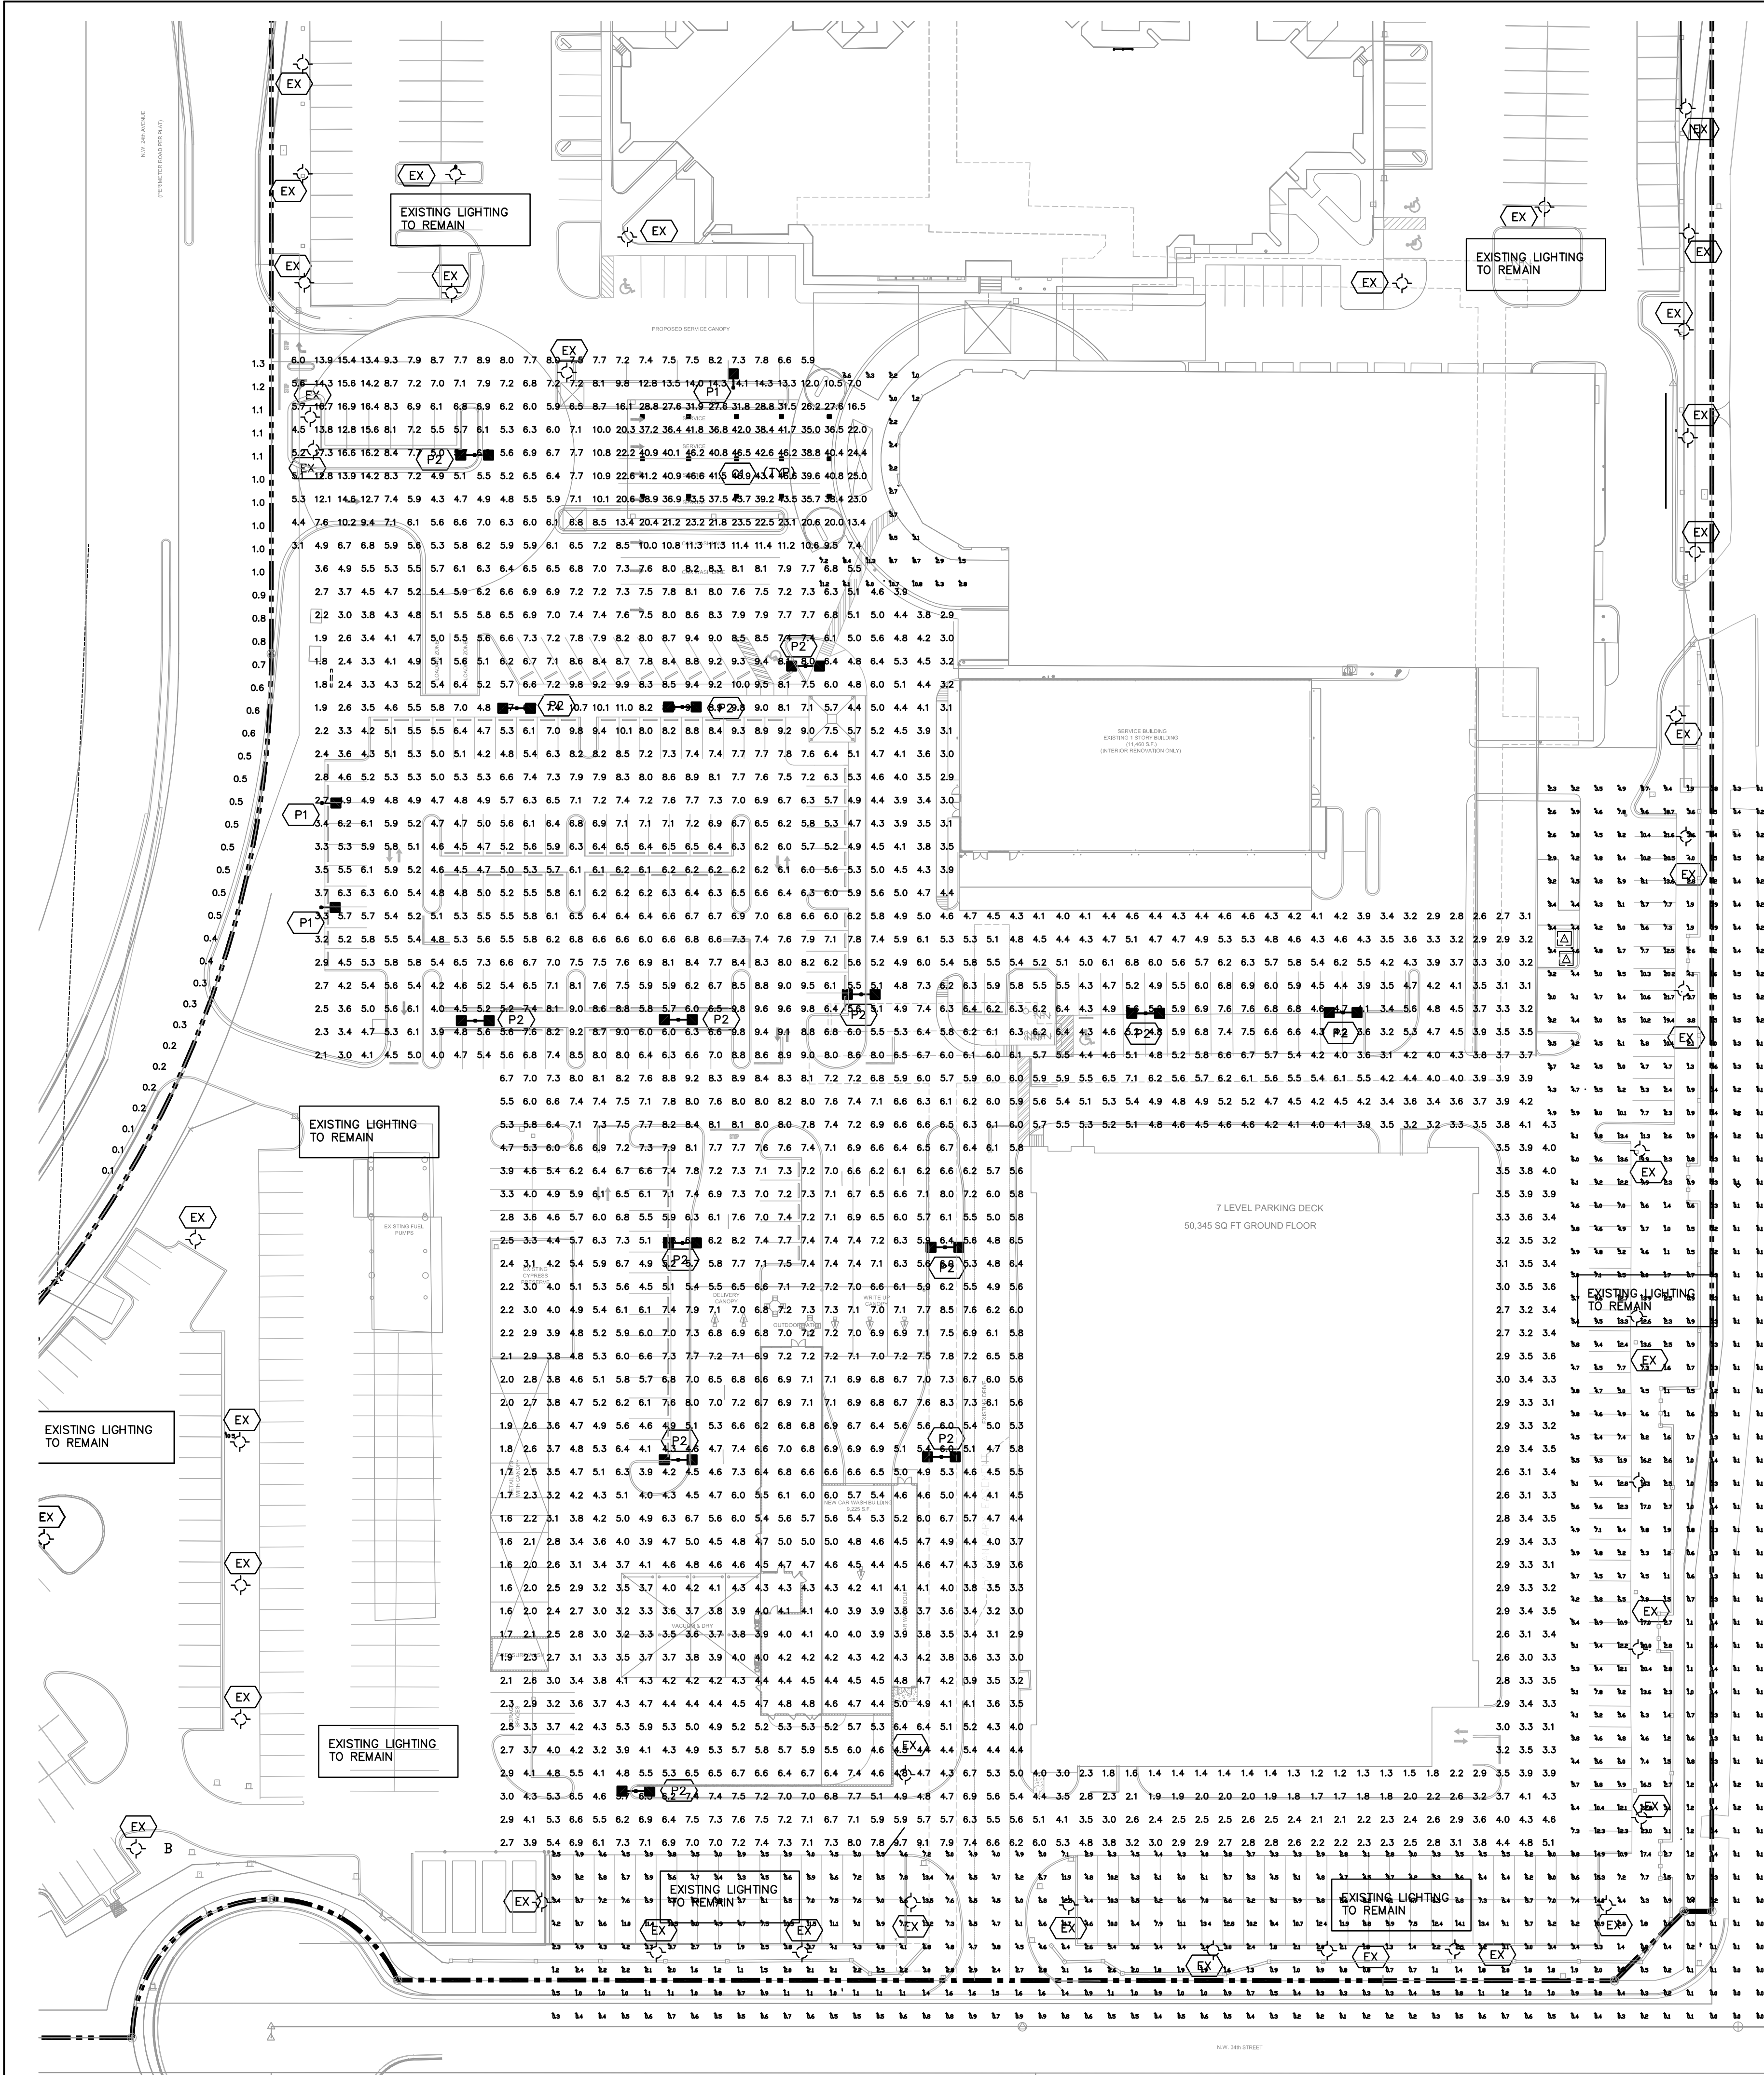

ELECTRICAL SHEET INDEX	
SHEET#	DESCRIPTION
E1.1	SITE PHOTOMETRIC PLAN, ELECTRICAL NOTES, LEGEND & INDEX

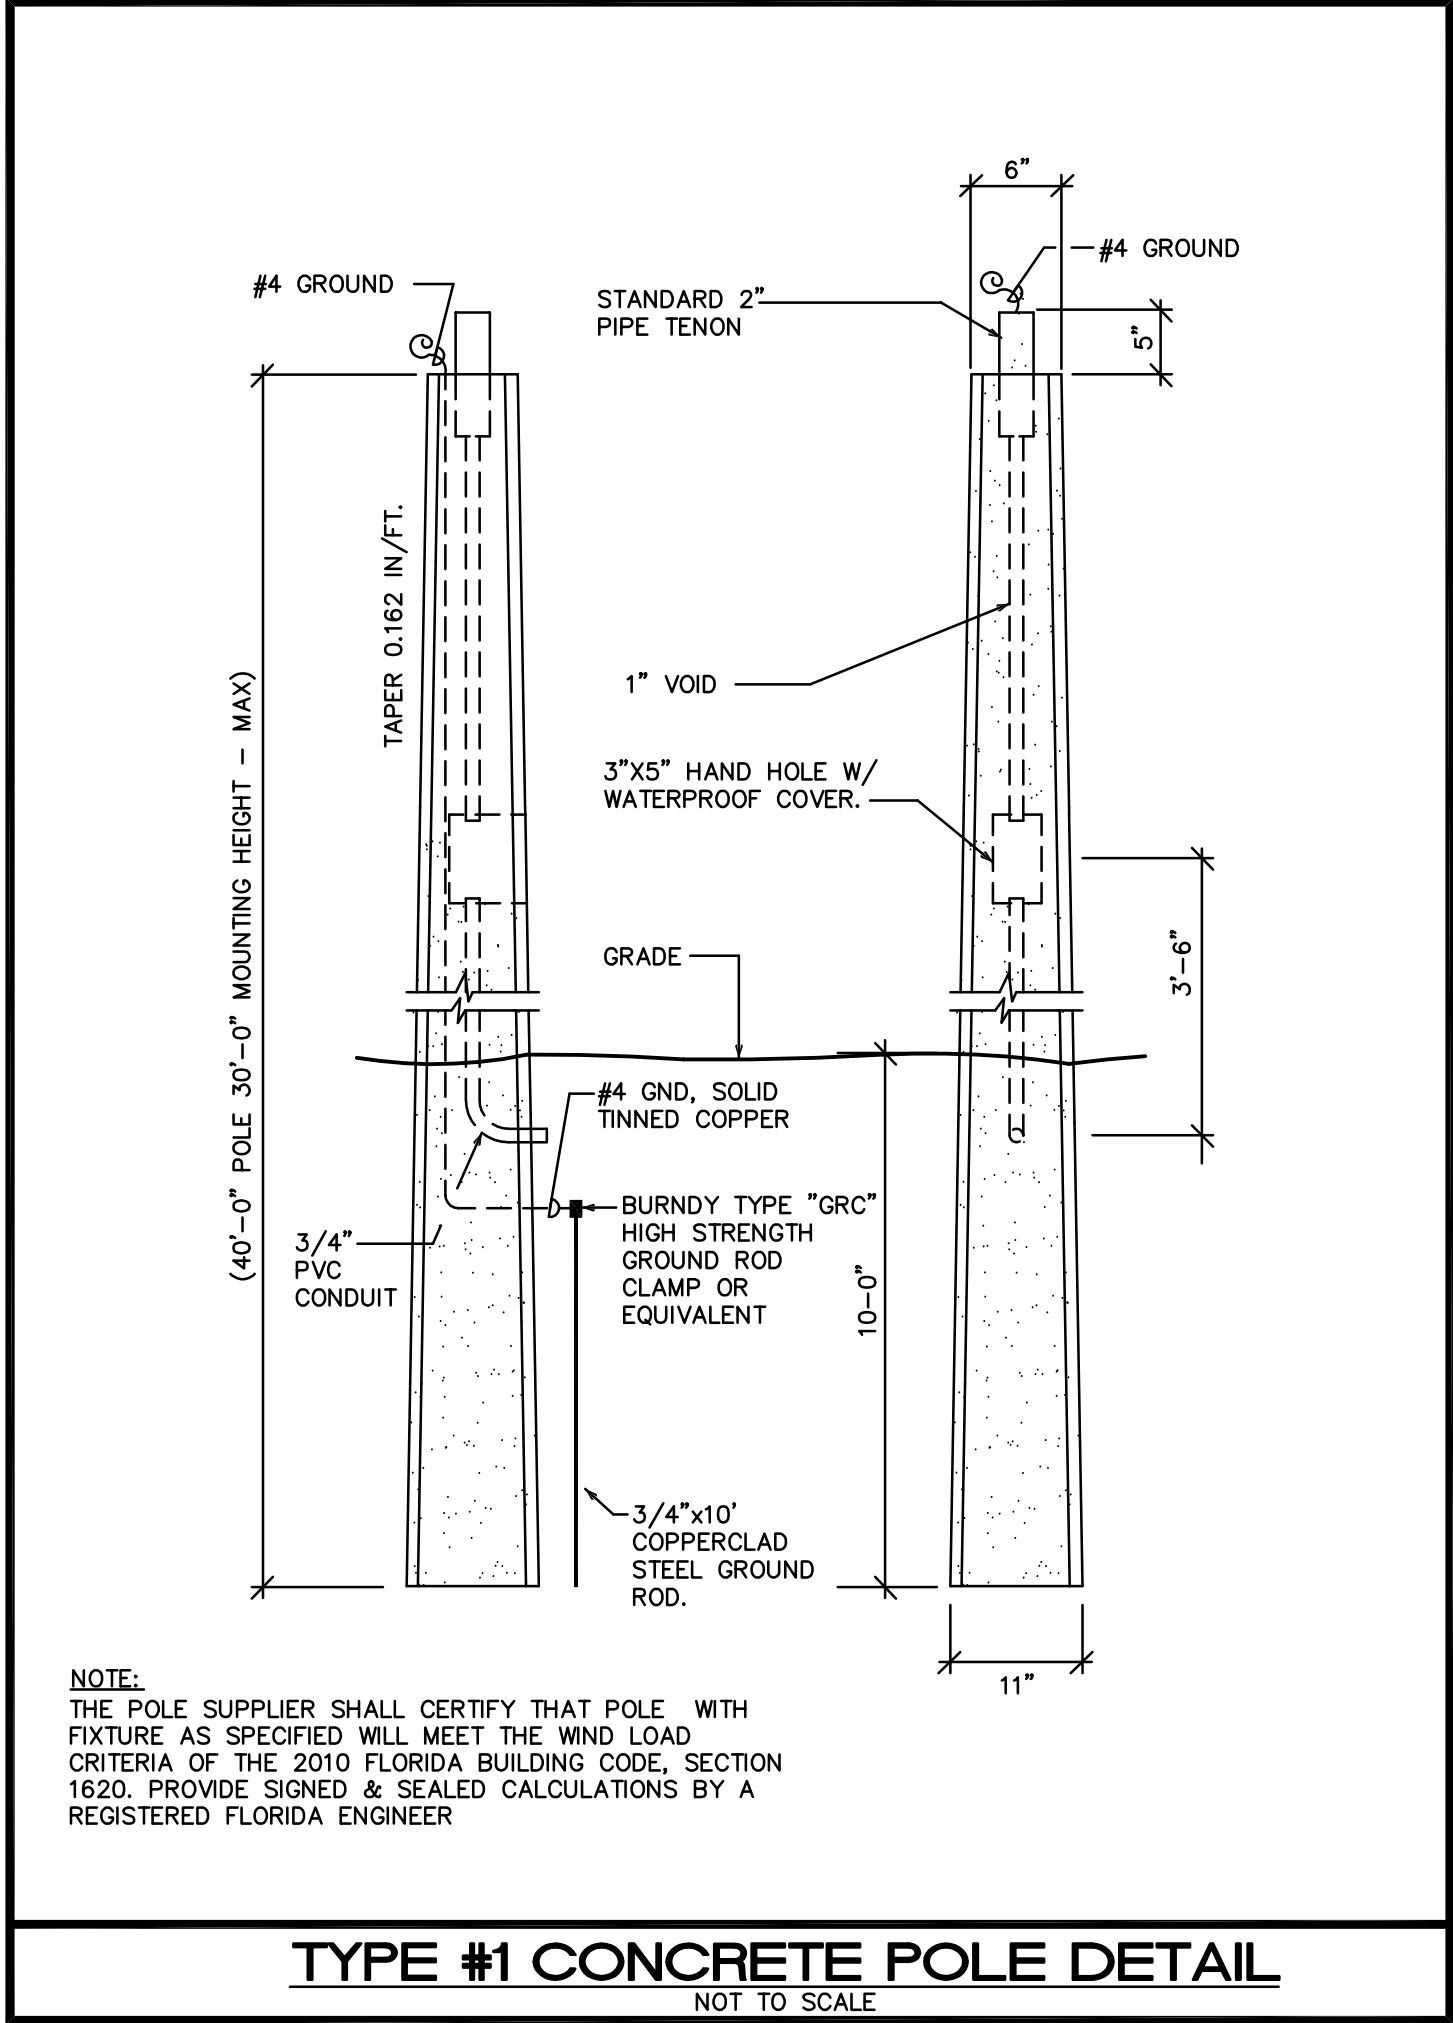

Luminaire Schedule							
Symbol	Label	[MANUFAC]	Description	Qty	Arrangement	Total Lamp Lumens	LLF Lum. Watts
EX	EX	LSI INDUSTRIES, INC	EXISTING LIGHTPOLE TO REMAIN				
C1	C1	LSI INDUSTRIES, INC	CRU-SC-LED-HO-CW	15	SINGLE	N.A.	0.840 150
P1	P1	LSI INDUSTRIES, INC	XAMU-3-LED-128-HO-CW-HSS	3	SINGLE	N.A.	0.840 179
P2	P2	LSI INDUSTRIES, INC	XSB-SX-LED-VHO-CW	14	D180	N.A.	0.840 487

Calculation Summary						
Label	CalcType	Units	Avg	Max	Min	Avg/Min Max/Min
Property line-West	Illuminance	Fc	0.67	1.5	N.A.	N.A. N.A.
CANOPY	Illuminance	Fc	32.89	46.9	13.4	2.45 3.50
NEW PARKING	Illuminance	Fc	5.97	17.3	1.6	3.73 10.81

SITE
PHOTOMETRIC PLAN

ISSUED FOR PERMIT	-
ISSUED FOR CONSTRUCTION	-
KAMM CONSULTING PROJECT # 2017-0450 PROJECT MANAGER: ART KAMM	
KAMM Consulting	1407 West Newport Center Drive Deerfield Beach, Florida 33442 Phone 954.949.2200 Fax 954.949.2201 engineering@kammconsulting.com Certification of Authorization #8189
07.06.2017	date
_____	signed

REVISIONS :

SEAL
CONSULTANT

STILES
ARCHITECTURAL GROUP
301 East Las Olas Blvd
Fort Lauderdale, Florida.
954 - 627- 9180
FL. REG # AA-26001798

A PROPOSED PARKING GARAGE AND
CAR WASH BUILDING FOR:
JM LEXUS OF MARGATE
5350 W SAMPLE RD,
MARGATE, FL 33073

SITE
PHOTOMETRIC PLAN

E1.1

PROJECT NO.
73907
DRAWN BY :
P.S./G.L.
CHECKED BY :
J.L.F.
DATE :
June 13, 2017

SITE PLAN APPROVAL