



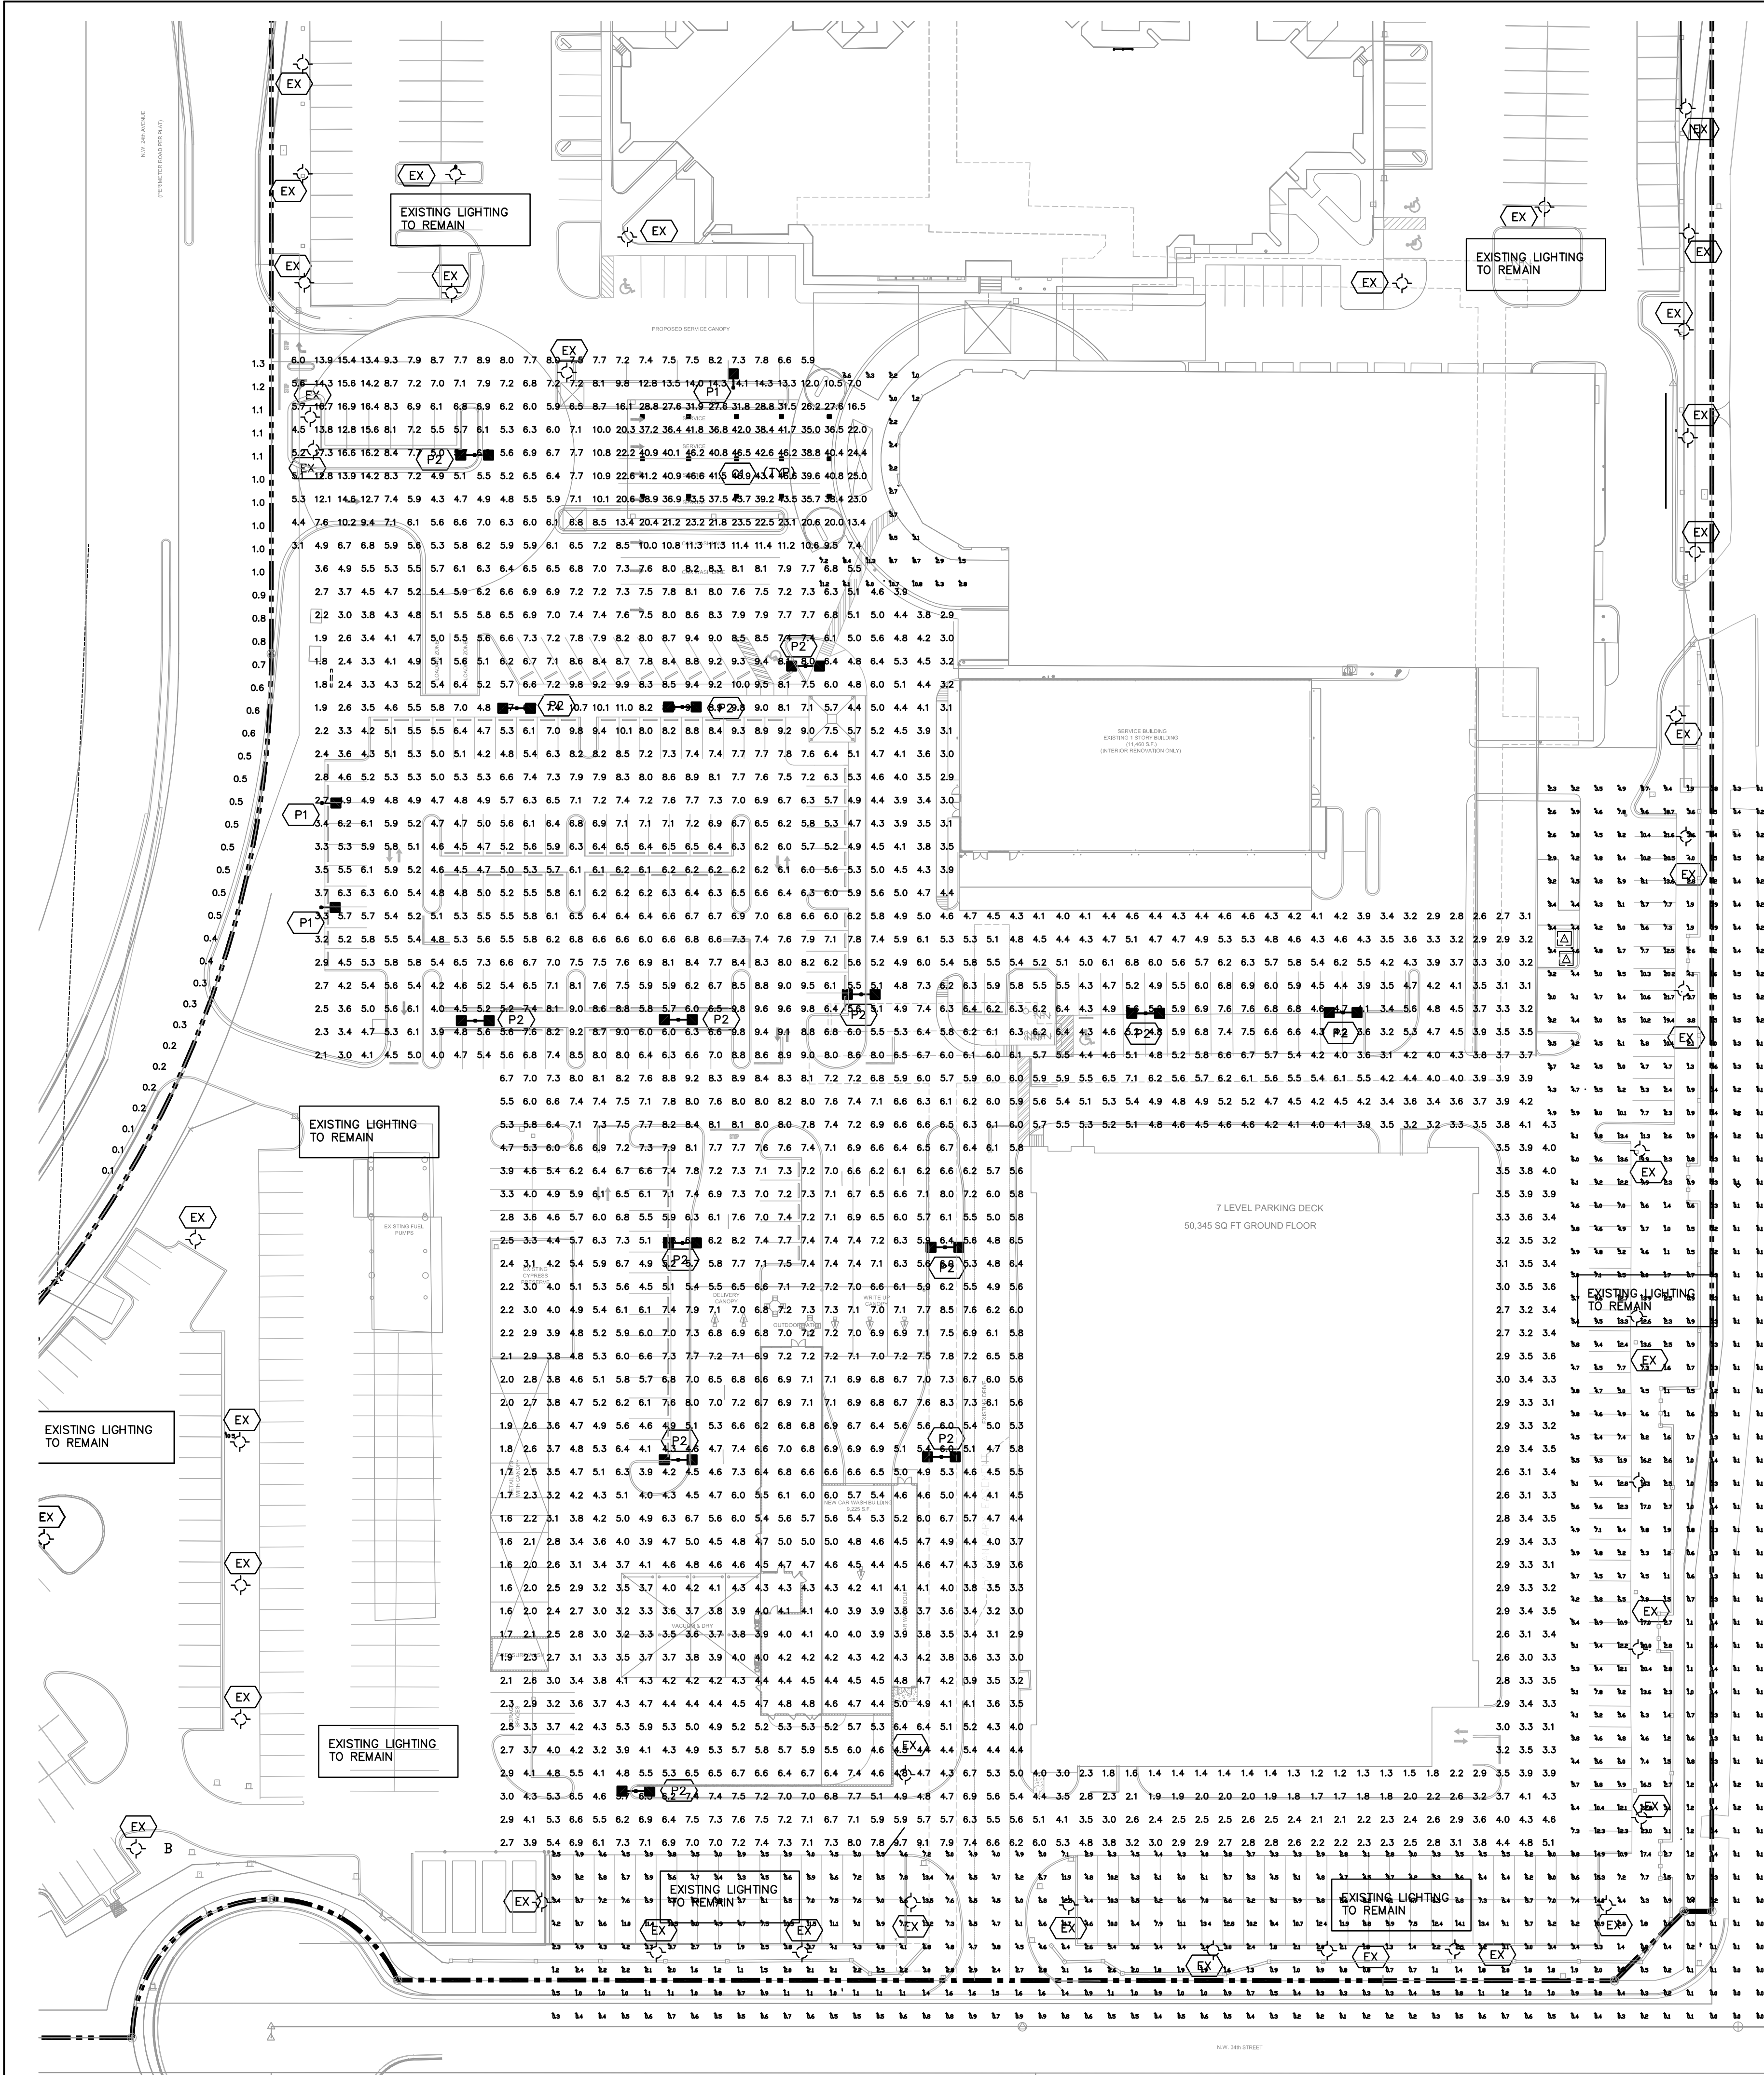

ELECTRICAL SHEET INDEX	
SHEET#	DESCRIPTION
E1.1	SITE PHOTOMETRIC PLAN, ELECTRICAL NOTES, LEGEND & INDEX

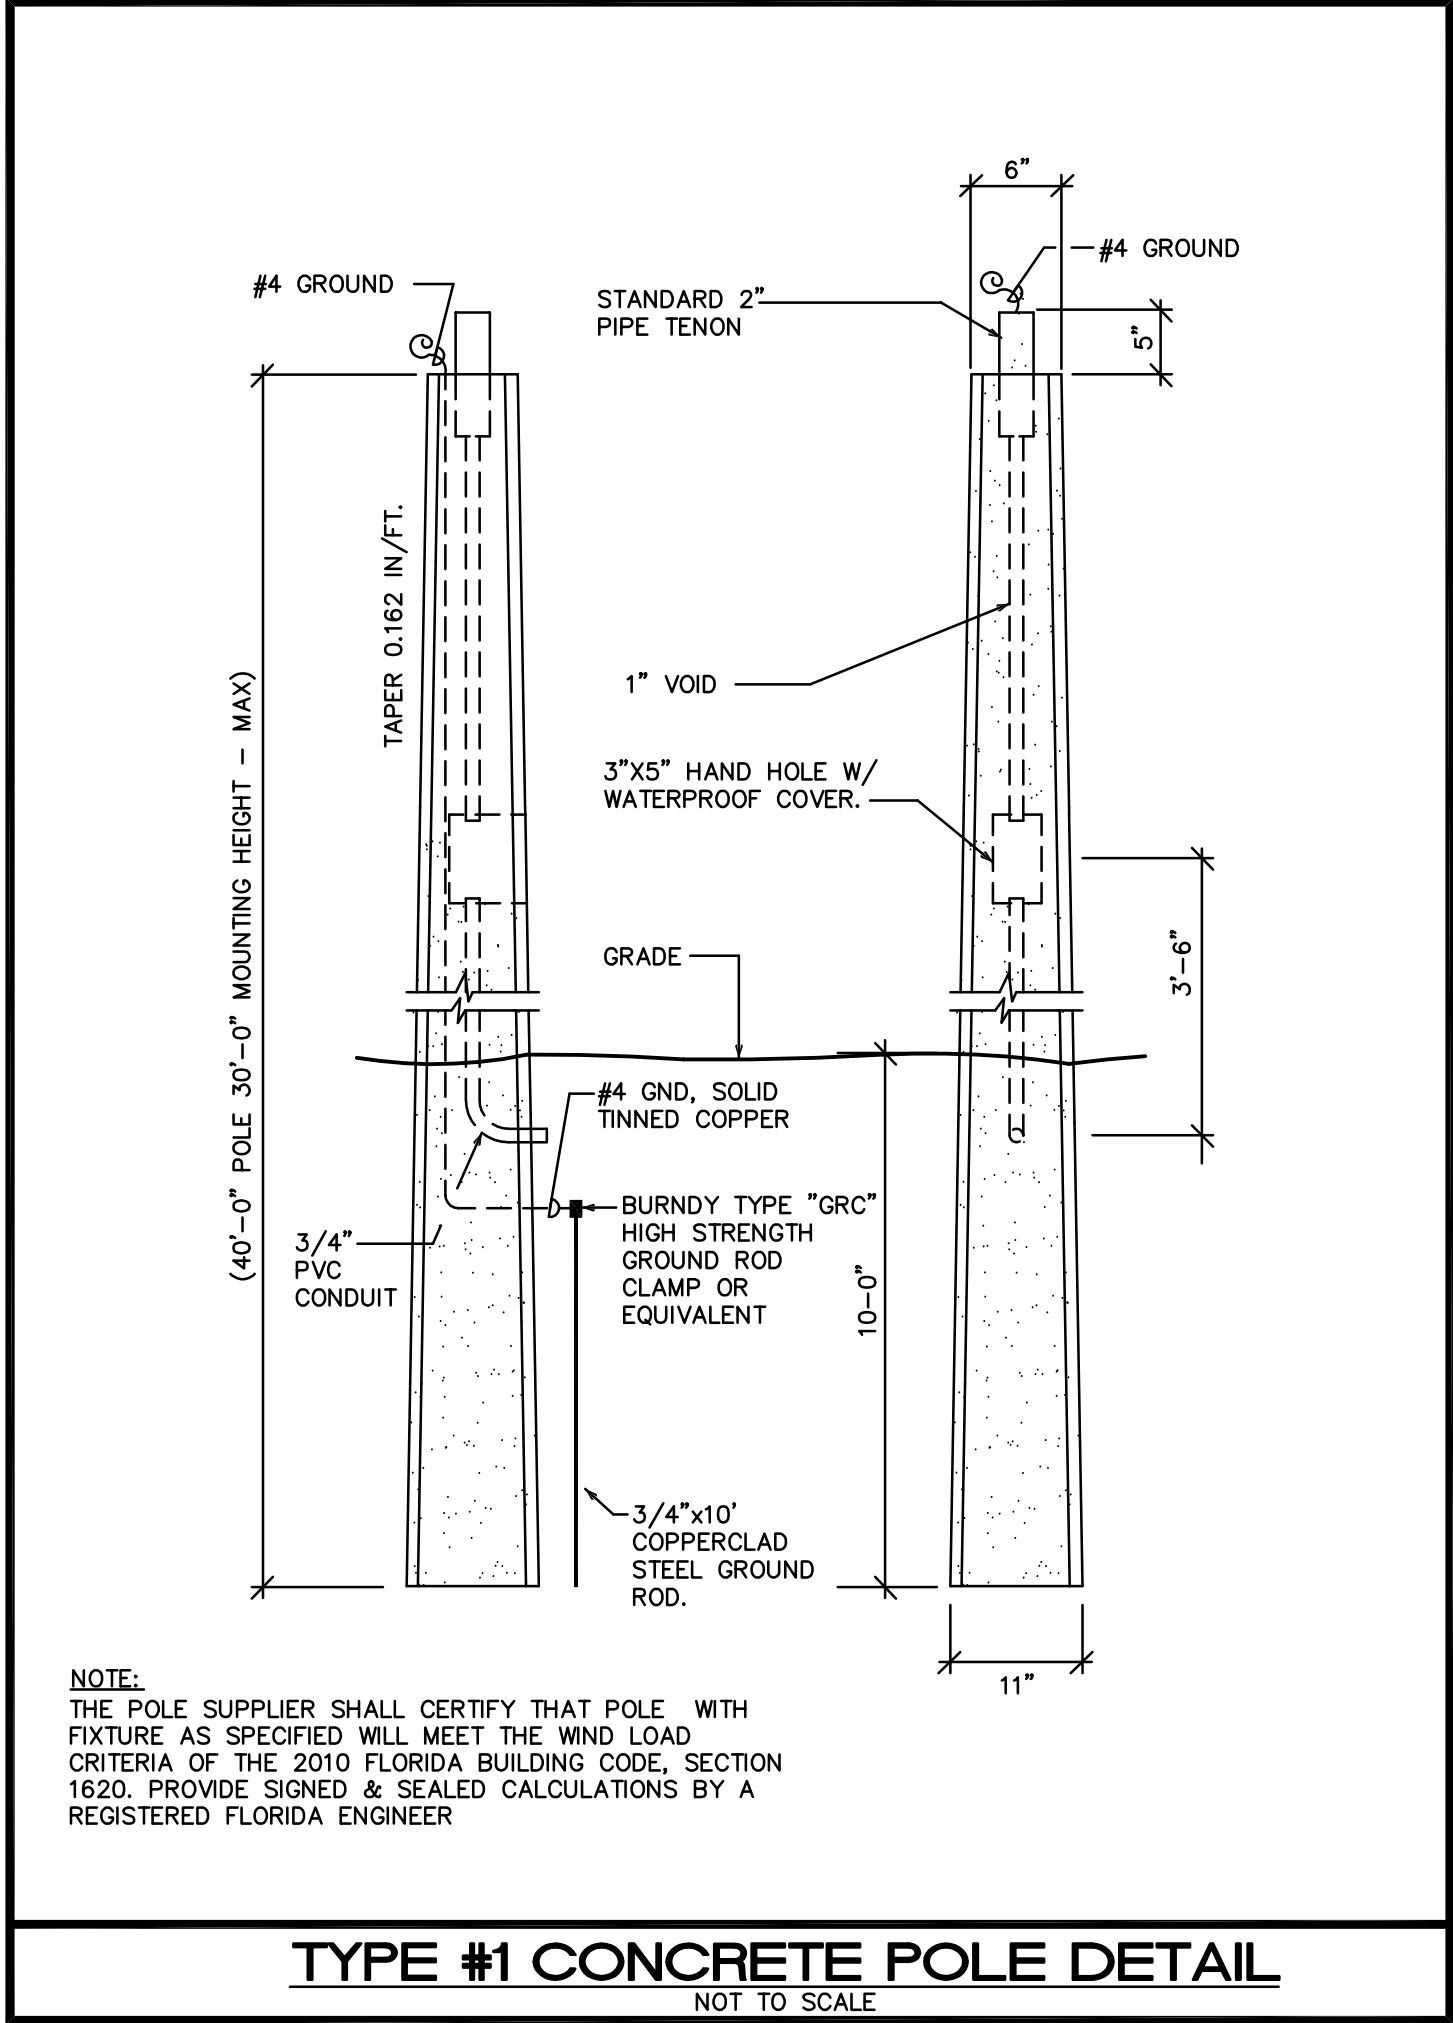

NOTE:
THE POLE SUPPLIER SHALL CERTIFY THAT POLE WITH
FIXTURE AS SPECIFIED WILL MEET THE WIND LOAD
CRITERIA OF THE 2010 FLORIDA BUILDING CODE, SECTION
1620. PROVIDE SIGNED & SEALED CALCULATIONS BY A
REGISTERED FLORIDA ENGINEER

Luminaire Schedule							
Symbol	Label	[MANUFAC]	Description	Qty	Arrangement	Total Lamp Lumens	LLF Lum. Watts
☆	EX	LSI INDUSTRIES, INC	EXISTING LIGHTPOLE TO REMAIN				
■	C1	LSI INDUSTRIES, INC	CRU-SC-LED-HO-CW	15	SINGLE	N.A.	0.840 150
■	P1	LSI INDUSTRIES, INC	XAMU-3-LED-128-HO-CW-HSS	3	SINGLE	N.A.	0.840 179
■	P2	LSI INDUSTRIES, INC	XSB-SX-LED-VHO-CW	14	D180	N.A.	0.840 487

Calculation Summary						
Label	CalcType	Units	Avg	Max	Min	Avg/Min Max/Min
Property line-West	Illuminance	Fc	0.67	1.5	N.A.	N.A.
CANOPY	Illuminance	Fc	32.89	46.9	13.4	2.45 3.50
NEW PARKING	Illuminance	Fc	5.97	17.3	1.6	3.73 10.81

SITE
PHOTOMETRIC PLAN
1"=40'-0" NORTH

ISSUED FOR PERMIT	-
ISSUED FOR CONSTRUCTION	-
KAMM CONSULTING PROJECT # 2017-0450	ART KAMM
KAMM Consulting	1407 West Newport Center Drive Deerfield Beach, Florida 33442 Phone 954.949.2200 Fax 954.949.2201 engineering@kammconsulting.com Certification of Authorization #8189
07.06.2017	date
_____	signed

REVISIONS :

SEAL
CONSULTANT

STILES ARCHITECTURAL GROUP
301 East Las Olas Blvd
Fort Lauderdale, Florida.
954 - 627- 9180
FL. REG # AA-26001798

A PROPOSED PARKING GARAGE AND
CAR WASH BUILDING FOR:
JM LEXUS OF MARGATE
5350 W SAMPLE RD,
MARGATE, FL 33073

SITE
PHOTOMETRIC PLAN

E1.1
PROJECT NO. 73907 DRAWN BY : P.S./G.L. CHECKED BY : J.L.F. DATE : June 13, 2017

SITE PLAN APPROVAL